

SURVEYED BY _____
 SUPERVISED BY _____
 DESIGNED BY _____


DESIGN FEATURES RELATING TO CONSTRUCTION
 OR TO REGULATION AND CONTROL OF TRAFFIC
 MAY BE SUBJECT TO CHANGE AS DEEMED
 NECESSARY BY THE DEPARTMENT

REVISED	FHWA REGION	STATE	FEDERAL AID		STATE		SHEET NO.
			PROJECT	ROUTE	PROJECT		

Section V - Roadway Lighting

Appendix VA-1

ROADWAY LIGHTING PLAN INDEX

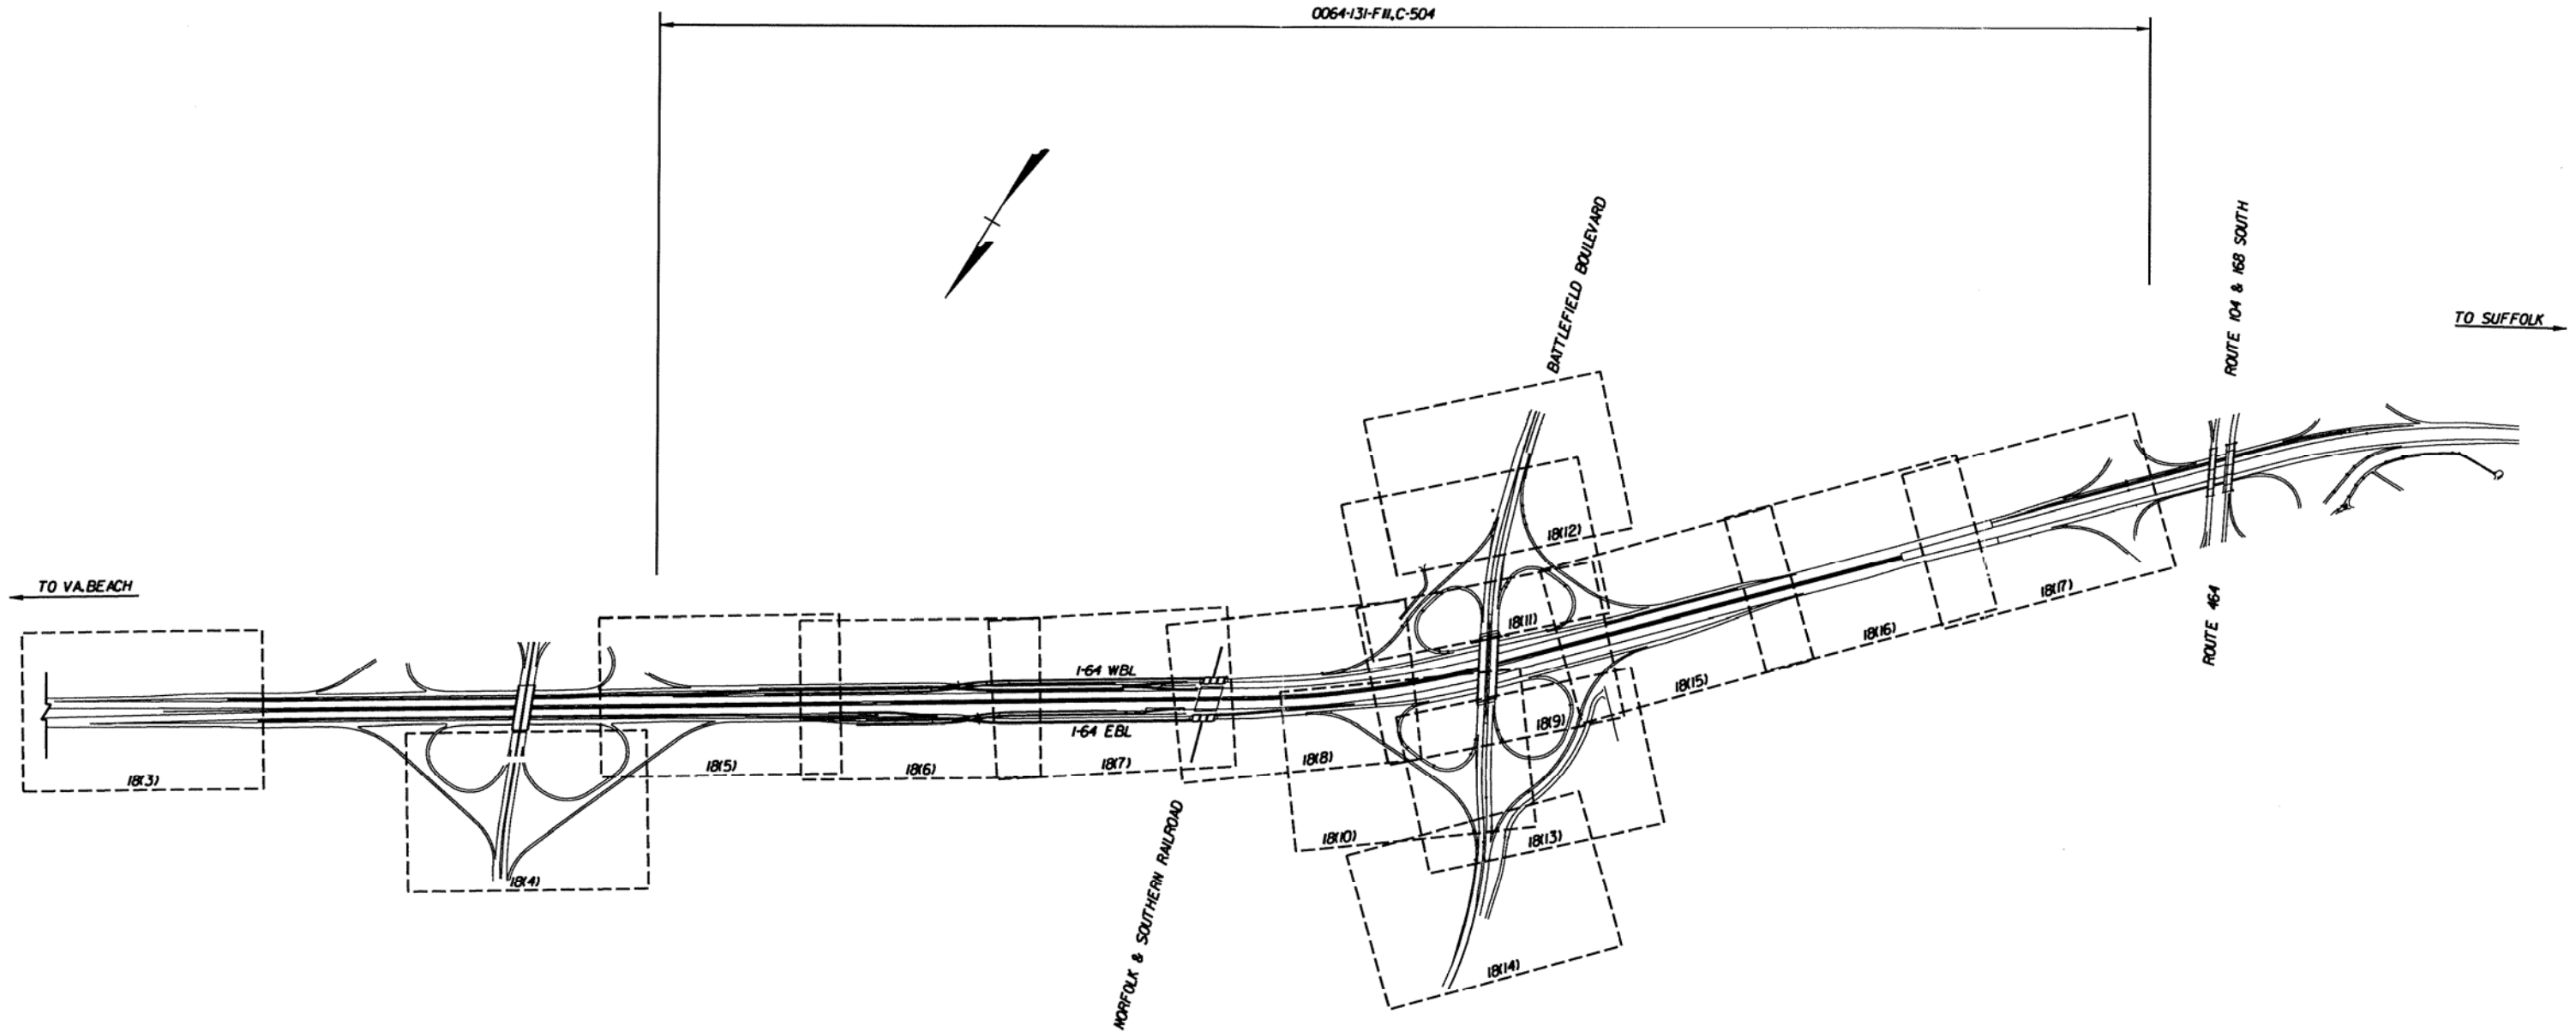

PLAN NO.	PROJECT	FILE NO.	SHEET NO.
A			